


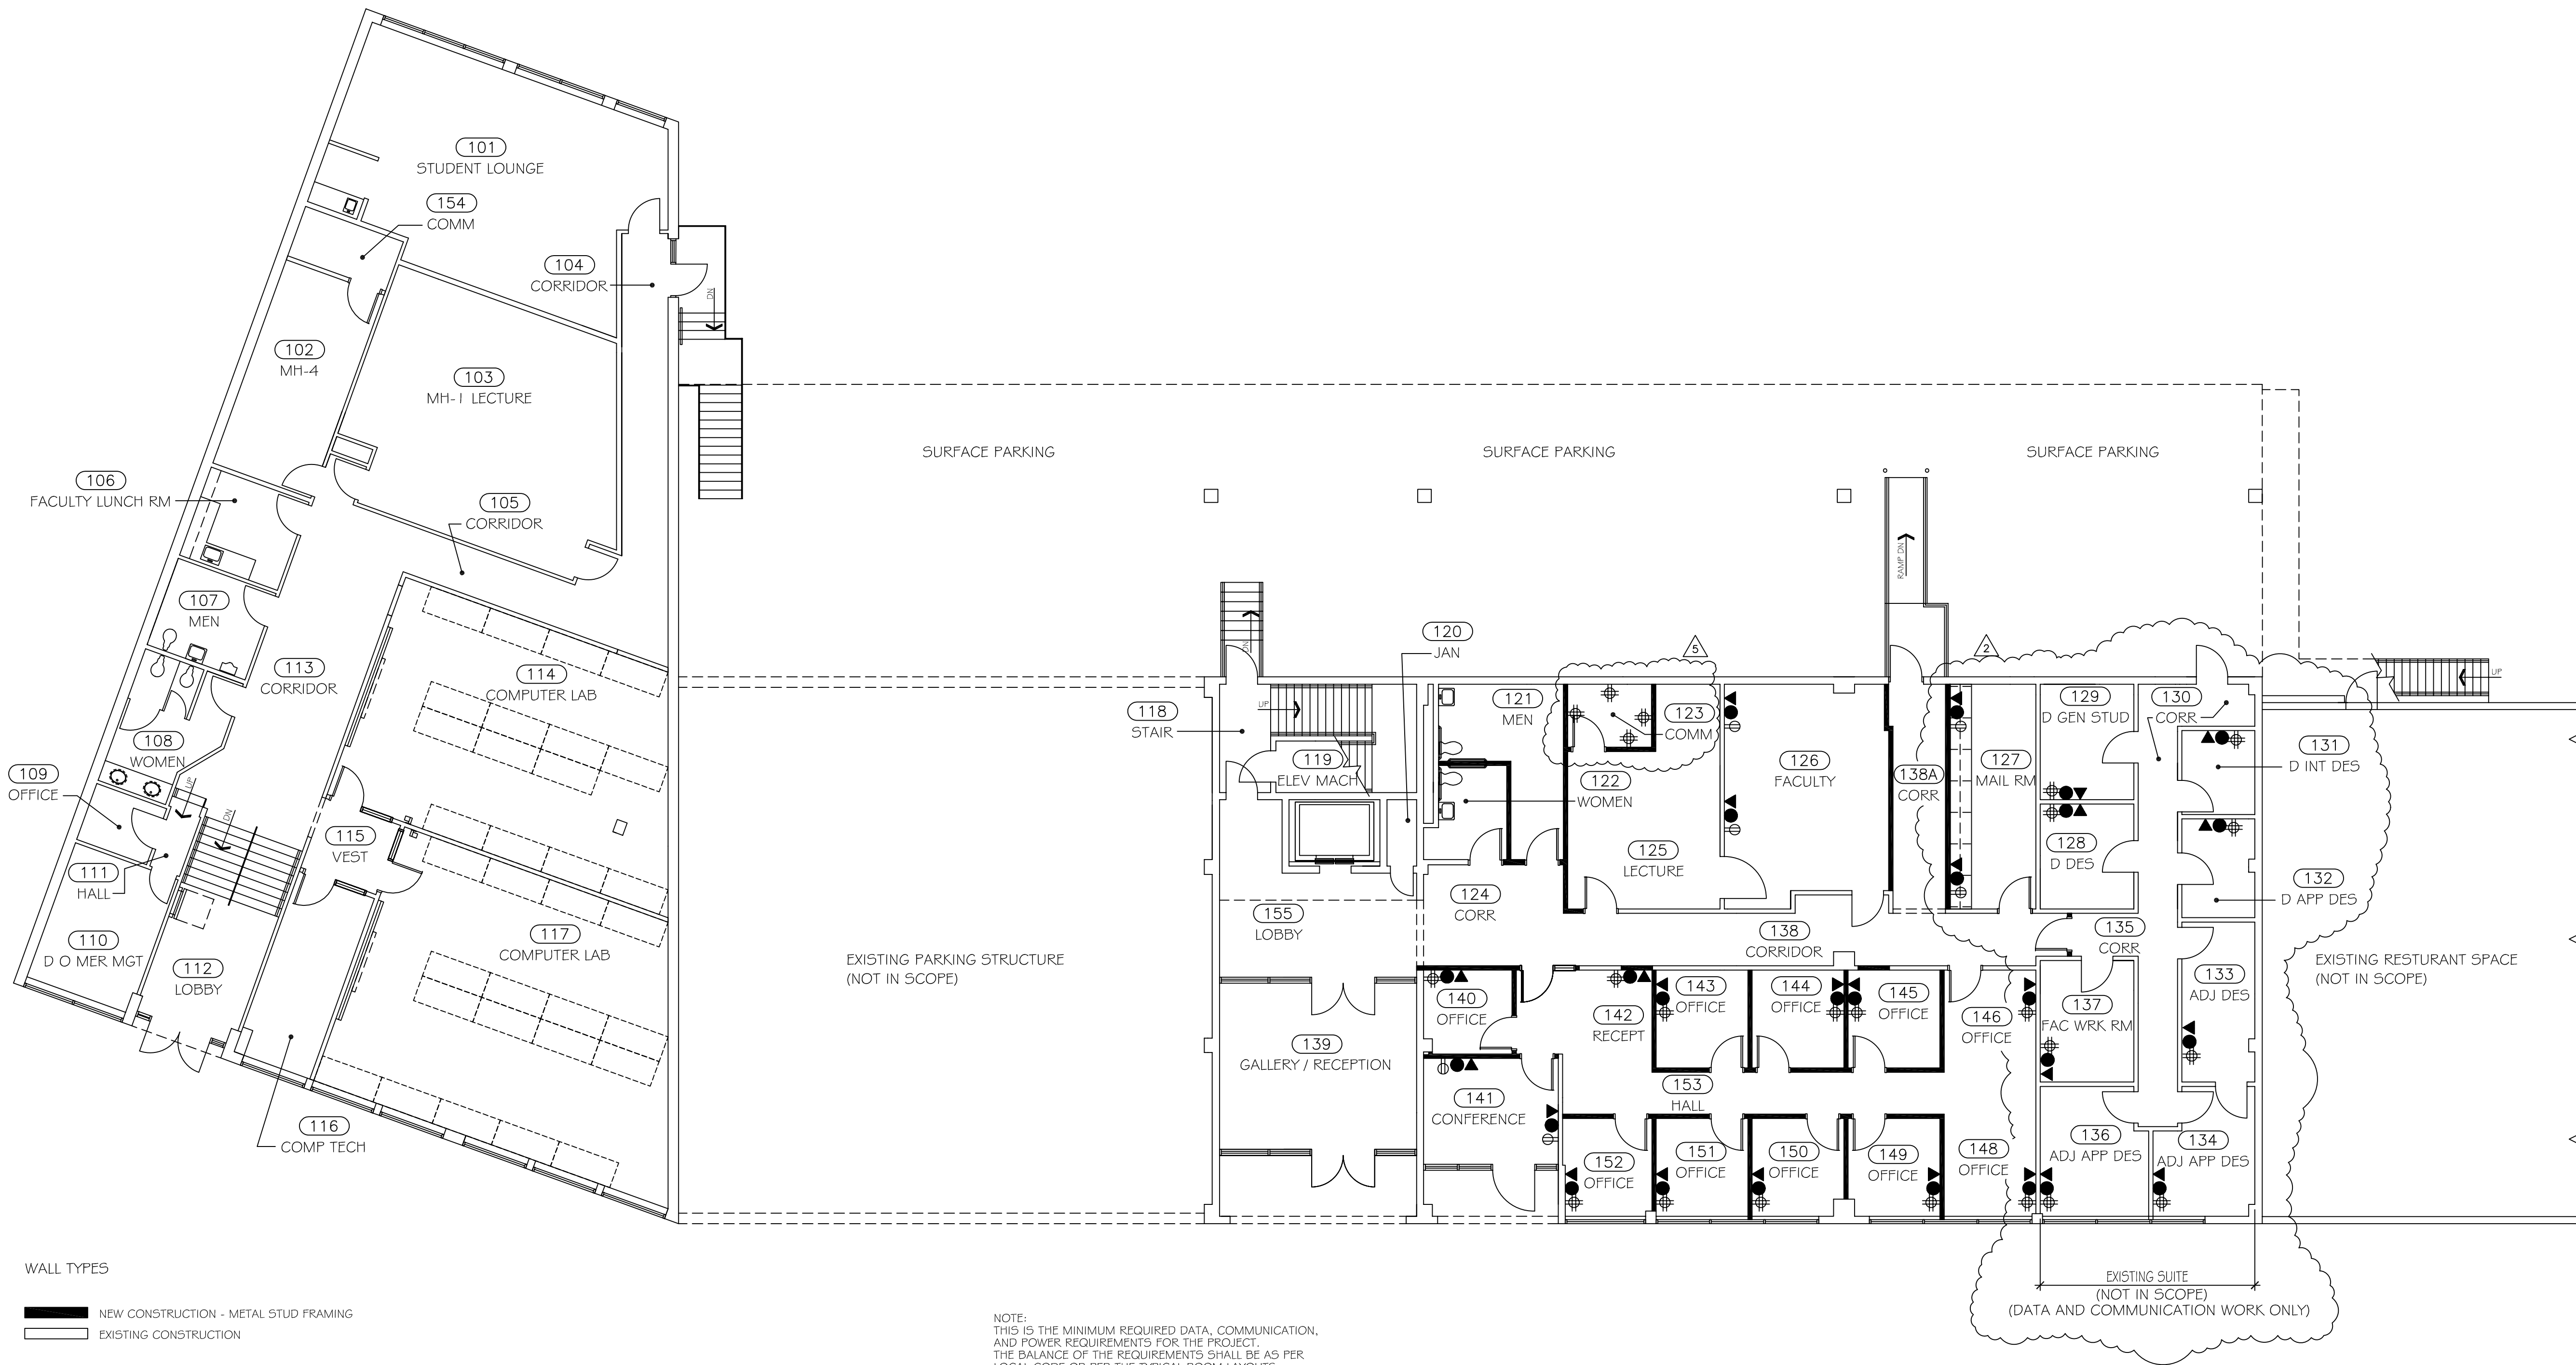

WALL TYPES

- NEW CONSTRUCTION - METAL STUD FRAMING
- EXISTING CONSTRUCTION

1  
1/8" = 1'-0"

## FIRST FLOOR COMMUNICATION / POWER PLAN

NOTE:  
THIS IS THE MINIMUM REQUIRED DATA, COMMUNICATION,  
AND POWER REQUIREMENTS FOR THE PROJECT.  
THE BALANCE OF THE REQUIREMENTS SHALL BE AS PER  
LOCAL CODE OR PER THE TYPICAL ROOM LAYOUTS.

- NOTE:  
DATA AND VOICE RUNS SHALL BE MOUNTED TOGETHER IN A  
SINGLE GANG BOX WITH A FOUR (4) OUTLET SINGLE FACE PLATE.
- CAT 3 VOICE  
SINGLE RUNS SPLIT INTO 2 JACKS FOR EACH SINGLE GANG BOX  
TERMINATE ON 66 BLOCK IN COMMUNICATION ROOM
- CAT 5 DATA  
DUAL RUNS FOR EACH SINGLE GANG BOX  
TERMINATE ON CAT 5 PATCH PANEL IN COMMUNICATION ROOM
- CAT 5 DATA  
SINGLE RUN FOR COMPUTER LABS  
TERMINATE ON CAT 5 PATCH PANEL IN COMMUNICATION ROOM  
USE SEPARATE RACK FOR COMPUTER LAB TERMINATION

- DUPLEX OUTLET
- QUADPLEX OUTLET

- MODULAR OFFICE OUTLET WITH PIGTAIL (FURNISHED WITH  
MODULAR OFFICE). INSTALLATION OF WIRING MUST BE  
COORDINATED CLOSELY WITH FURNITURE INSTALLERS.
- SPECIAL WIRE RUNS FOR FREE STANDING MODULAR  
OFFICE FURNITURE. DATA AND VOICE WIRING NEEDS  
TO BE RUN THROUGH RACEWAYS OF EACH MODULAR WALL,  
AND TERMINATED INTO SPECIFIED OUTLET ON MODULAR  
UNIT. LOCATION OF JACK DEPENDS ON LOCATION OF  
WORKSTATION AREA.
- EACH FREE STANDING MODULAR OFFICE NEEDS TO HAVE  
POWER WIRING DIRECTLY INTO THE PIGTAIL COMING FROM  
THE MODULAR OFFICE OUTLET.

- 19" X 7" ALUMINUM NETWORK RACK.  
A MINIMUM OF 2'-0" CLEAR MUST BE MAINTAINED  
AROUND NETWORK RACK.

NOTE:  
COMMUNICATION ROOM SHALL BE WIRED WITH A MINIMUM  
OF (3) THREE DEDICATED POWER CIRCUITS ( 110V - 20A ).  
EACH DEDICATED CIRCUIT SHALL RECEIVE A QUADPLEX  
OUTLET. EACH OUTLET SHALL BE INSTALLED ON A DIFFERENT  
WALL IN THE COMMUNICATION ROOM. (SEE PLAN).  
FURNISH AND INSTALL 4" X 8" X 3/4" PLYWOOD ON BACK  
WALL FOR TELEPHONE COMPANY EQUIPMENT.

50 PAIR FEEDER CABLE SHALL ALWAYS BE RUN FROM  
DEMARKATION POINT TO COMMUNICATIONS ROOM.  
TERMINATE ON 66 BLOCK IN COMMUNICATION ROOM.

COMPUTER LABS SHALL BE WIRED WITH WIREMOLD SERIES  
4000 METAL RACEWAY OR APPROVED EQUAL. WHERE TABLES  
ARE AGAINST A WALL MOUNT THE RACEWAY ON THE WALL  
1 FT AFF. WHERE THE TABLES ARE FREE STANDING IN THE  
ROOM MOUNT THE RACEWAY ON THE FLOOR UNDER THE  
TABLES AT THE BACK OF THE TABLES.

ISSUE DATE:  
**12 JUN 1998**

|            |                |
|------------|----------------|
| PLOT DATE: | 19 APR 1999    |
| REV NO:    | REVISION DATE: |
| 1          | 08 JAN 1999    |
| 2          | 09 FEB 1999    |
| 3          | 24 FEB 1999    |
| 5          | 19 APR 1999    |

PROJECT NUMBER:  
**98-04**

RENOVATIONS TO THE  
**ART INSTITUTES INTL @ PORTLAND**  
2000 SW FIFTH AVENUE  
PORTLAND, OR 97201-4972  
**EDUCATION MANAGEMENT CORPORATION**  
300 SIXTH AVENUE  
PITTSBURGH, PENNSYLVANIA 15222

**EDUCATION  
MANAGEMENT  
CORPORATION**  
**FACILITIES  
DIVISION**

219 NORTH MAIN STREET  
PITTSBURGH, PA. 15215-2020  
PHONE NO. (412) 562-0900  
FAX NO. (412) 781-6671

1ST FLOOR  
COMM / POWER PLAN

DRAWING NUMBER:  
**CP11**

