


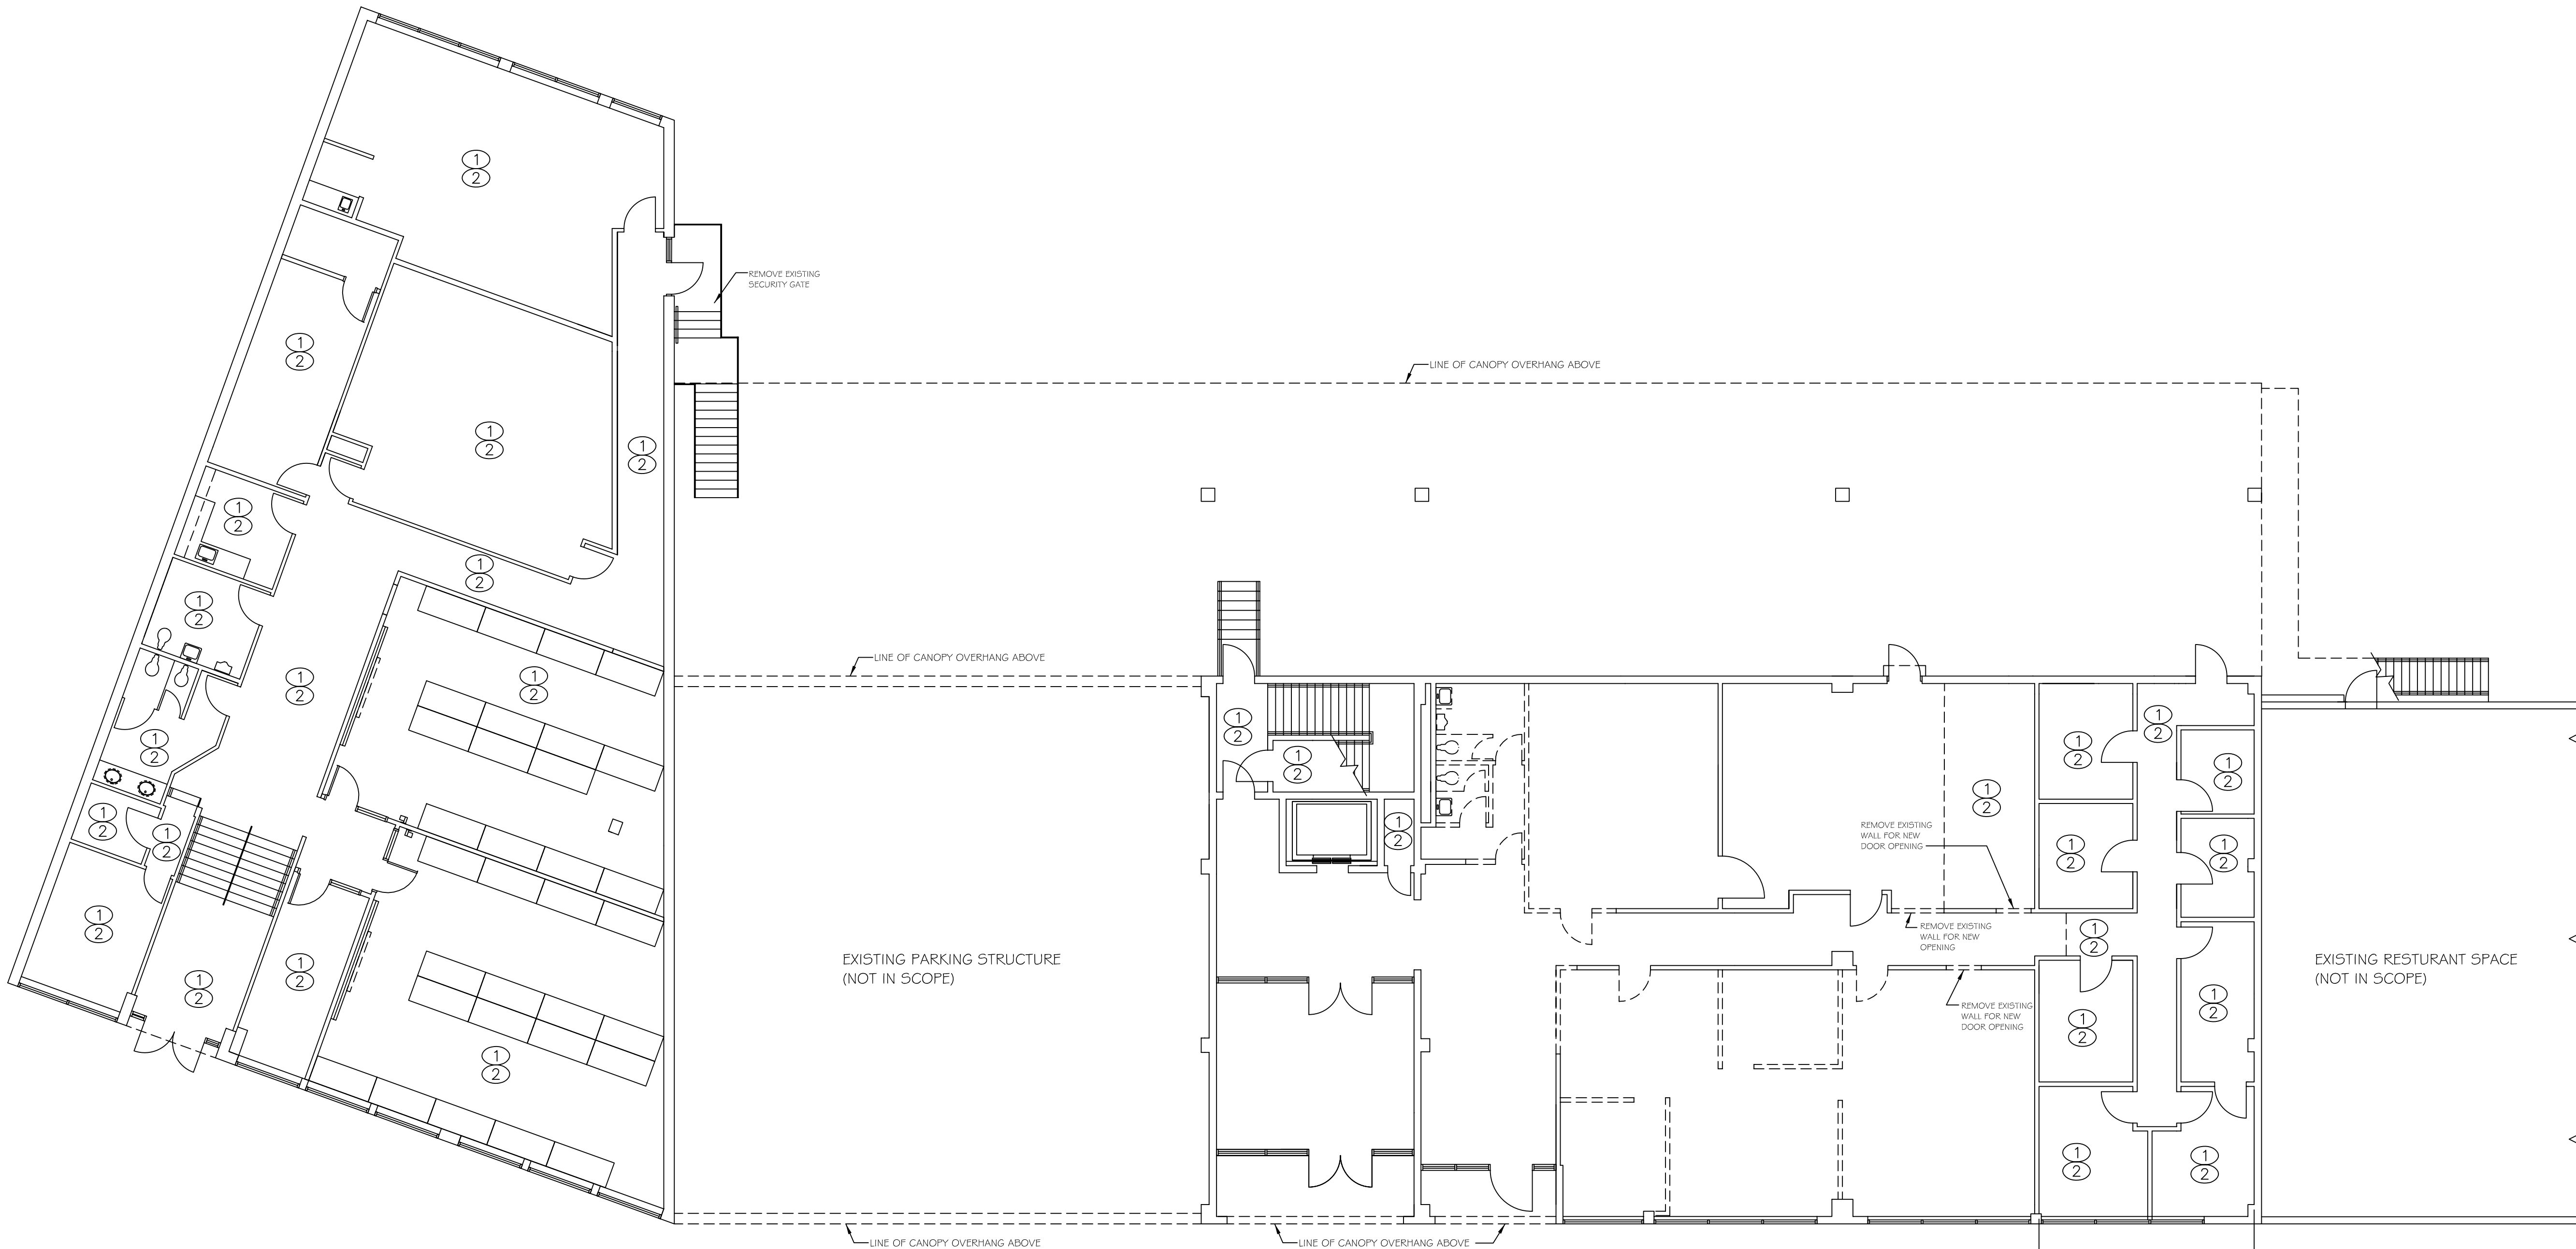

WALL TYPES

- EXISTING CONSTRUCTION
EXISTING CONSTRUCTION TO BE REMOVED (U.N.O.)

FIRST FLOOR DEMOLITION PLAN

1
1/8" = 1'-0"

DEMOLITION NOTES

REMOVE ALL HVAC EQUIPMENT AND DUCT WORK BY HVAC CONTRACTOR AS REQUIRED
REMOVE ALL PLUMBING FIXTURES AND PLUMBING BY PLUMBING CONTRACTOR AS REQUIRED
REMOVE ALL LIGHT FIXTURES AND ELECTRICAL DEVICES BY ELECTRIC CONTRACTOR AS REQUIRED
REMOVE ALL WALLS, EQUIPMENT, AND CASEWORK AS INDICATED ON PLANS
REMOVE ALL FLOOR FINISHES AND BASE (U.N.O.)
REMOVE ALL CEILINGS, CEILING GRIDS, AND CEILING STRUCTURE (U.N.O.)
REMOVE ALL DOORS AND FRAMES AS INDICATED ON PLANS

- ① EXISTING CEILING TO REMAIN
② EXISTING FLOOR FINISH AND BASE TO REMAIN

ISSUE DATE:

12 JUN 1998

PLOT DATE:	25 FEB 1999
REV NO:	REVISION DATE:
1	08 JAN 1999
3	24 FEB 1999

PROJECT NUMBER:
98-04

RENOVATIONS TO THE
ART INSTITUTES INTL @ PORTLAND
2000 SW FIFTH AVENUE
PORTLAND, OR 97201-4972
EDUCATION MANAGEMENT CORPORATION
300 SIXTH AVENUE
PITTSBURGH, PENNSYLVANIA 15222

**EDUCATION
MANAGEMENT
CORPORATION**
**FACILITIES
DIVISION**

219 NORTH MAIN STREET
PITTSBURGH, PA. 15215-2020
PHONE NO. (412) 562-0900
FAX NO. (412) 781-6671

1ST FLOOR DEMO PLAN

DRAWING NUMBER:
D111

ENTIRE
SHEET