



12
I

FILE NO. V-1
PLOT TIME: 2:00 PM
PLOT DATE: 10/20/98

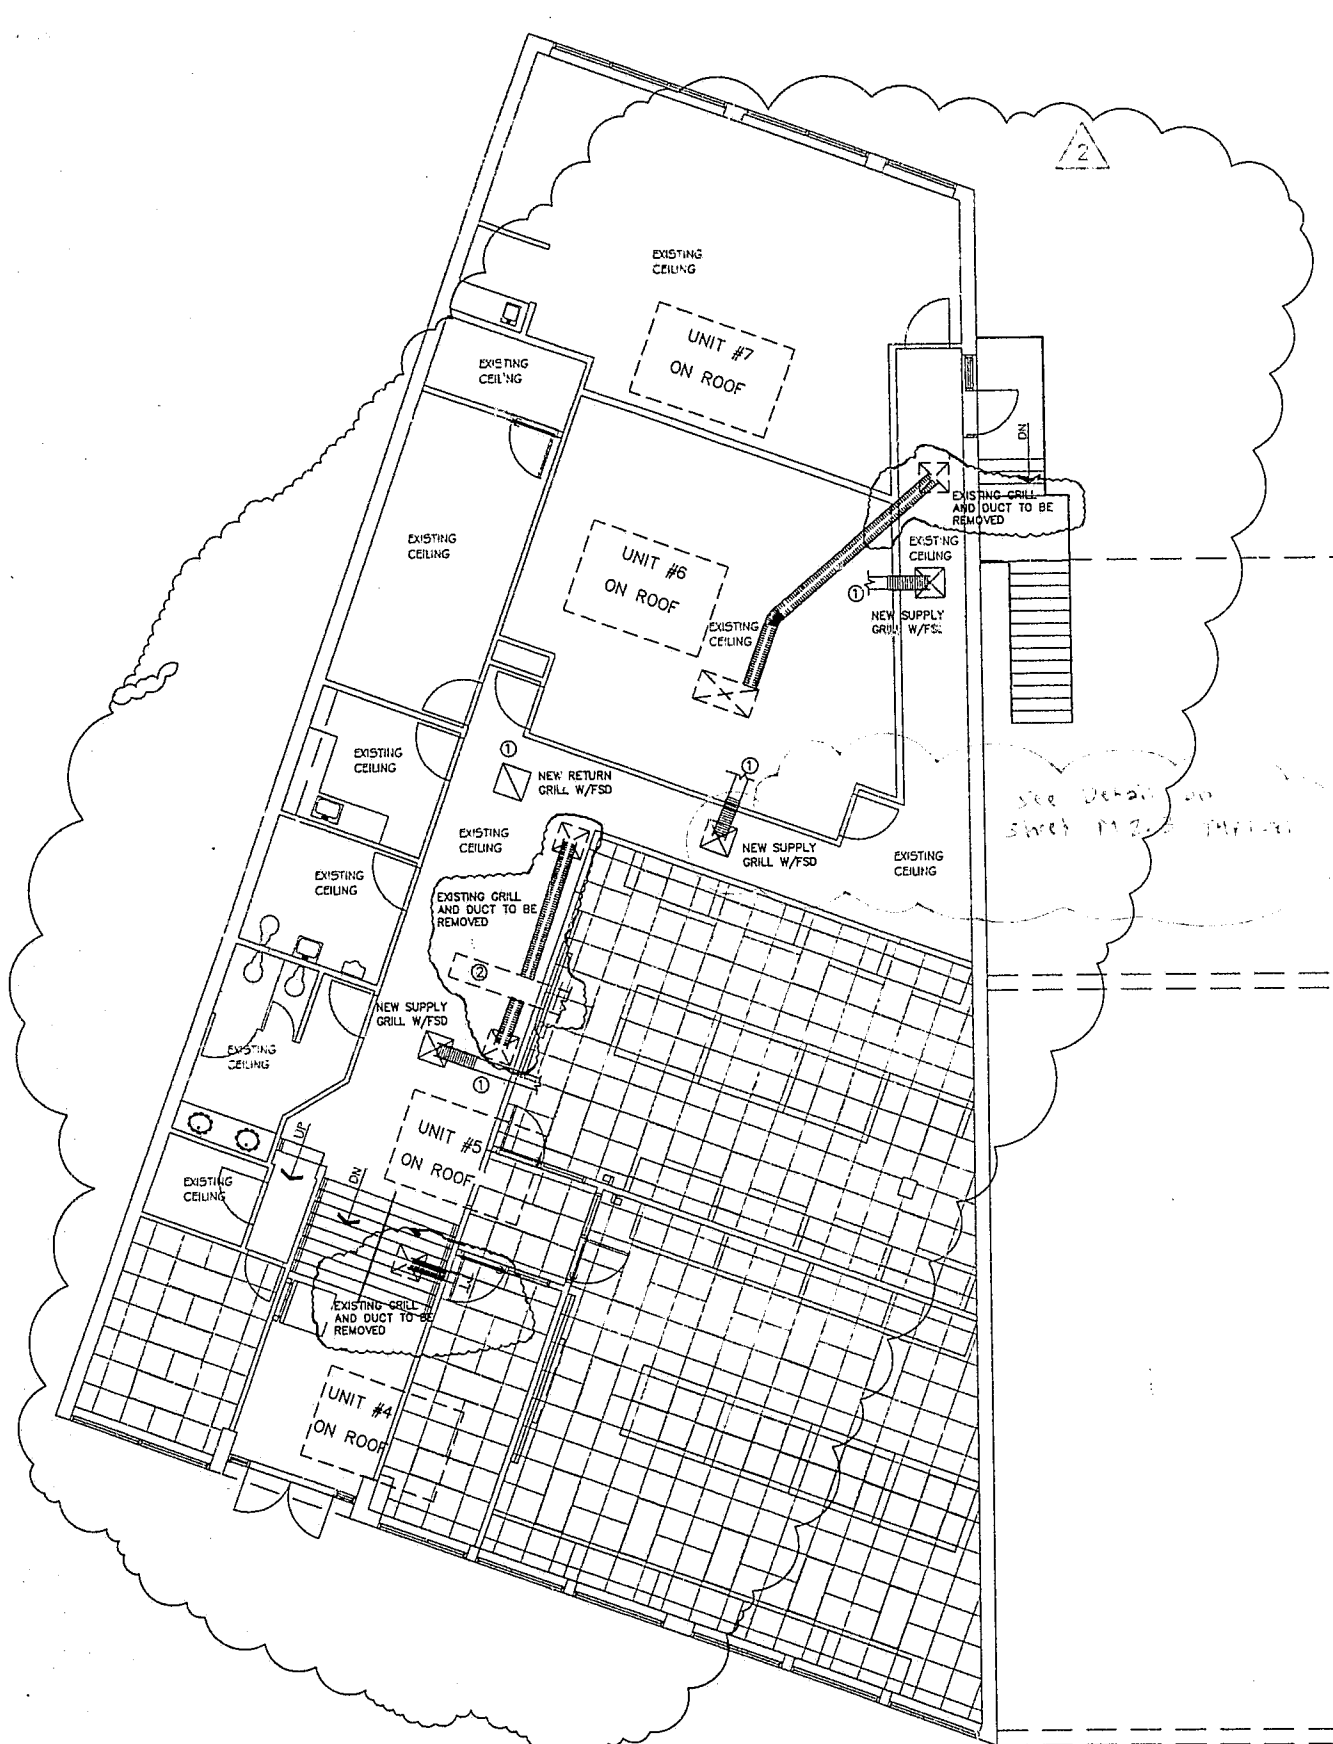

UNIT SCHEDULE			
NO.	MAKE	MODEL	SERIAL NO.
#4	DAY-NIGHT	542EP090000	Z487C11449
#5	CARRIER	5055042-501AD	2697G40609
#6	DAY-NIGHT	558CPX06000	UNREADABLE
#7	UNKNOWN	542GN036	UNREADABLE
#14	UNKNOWN	50R0008400JB	K988880
#15	LENNOX	LXP1-500FW-1	UNKNOWN

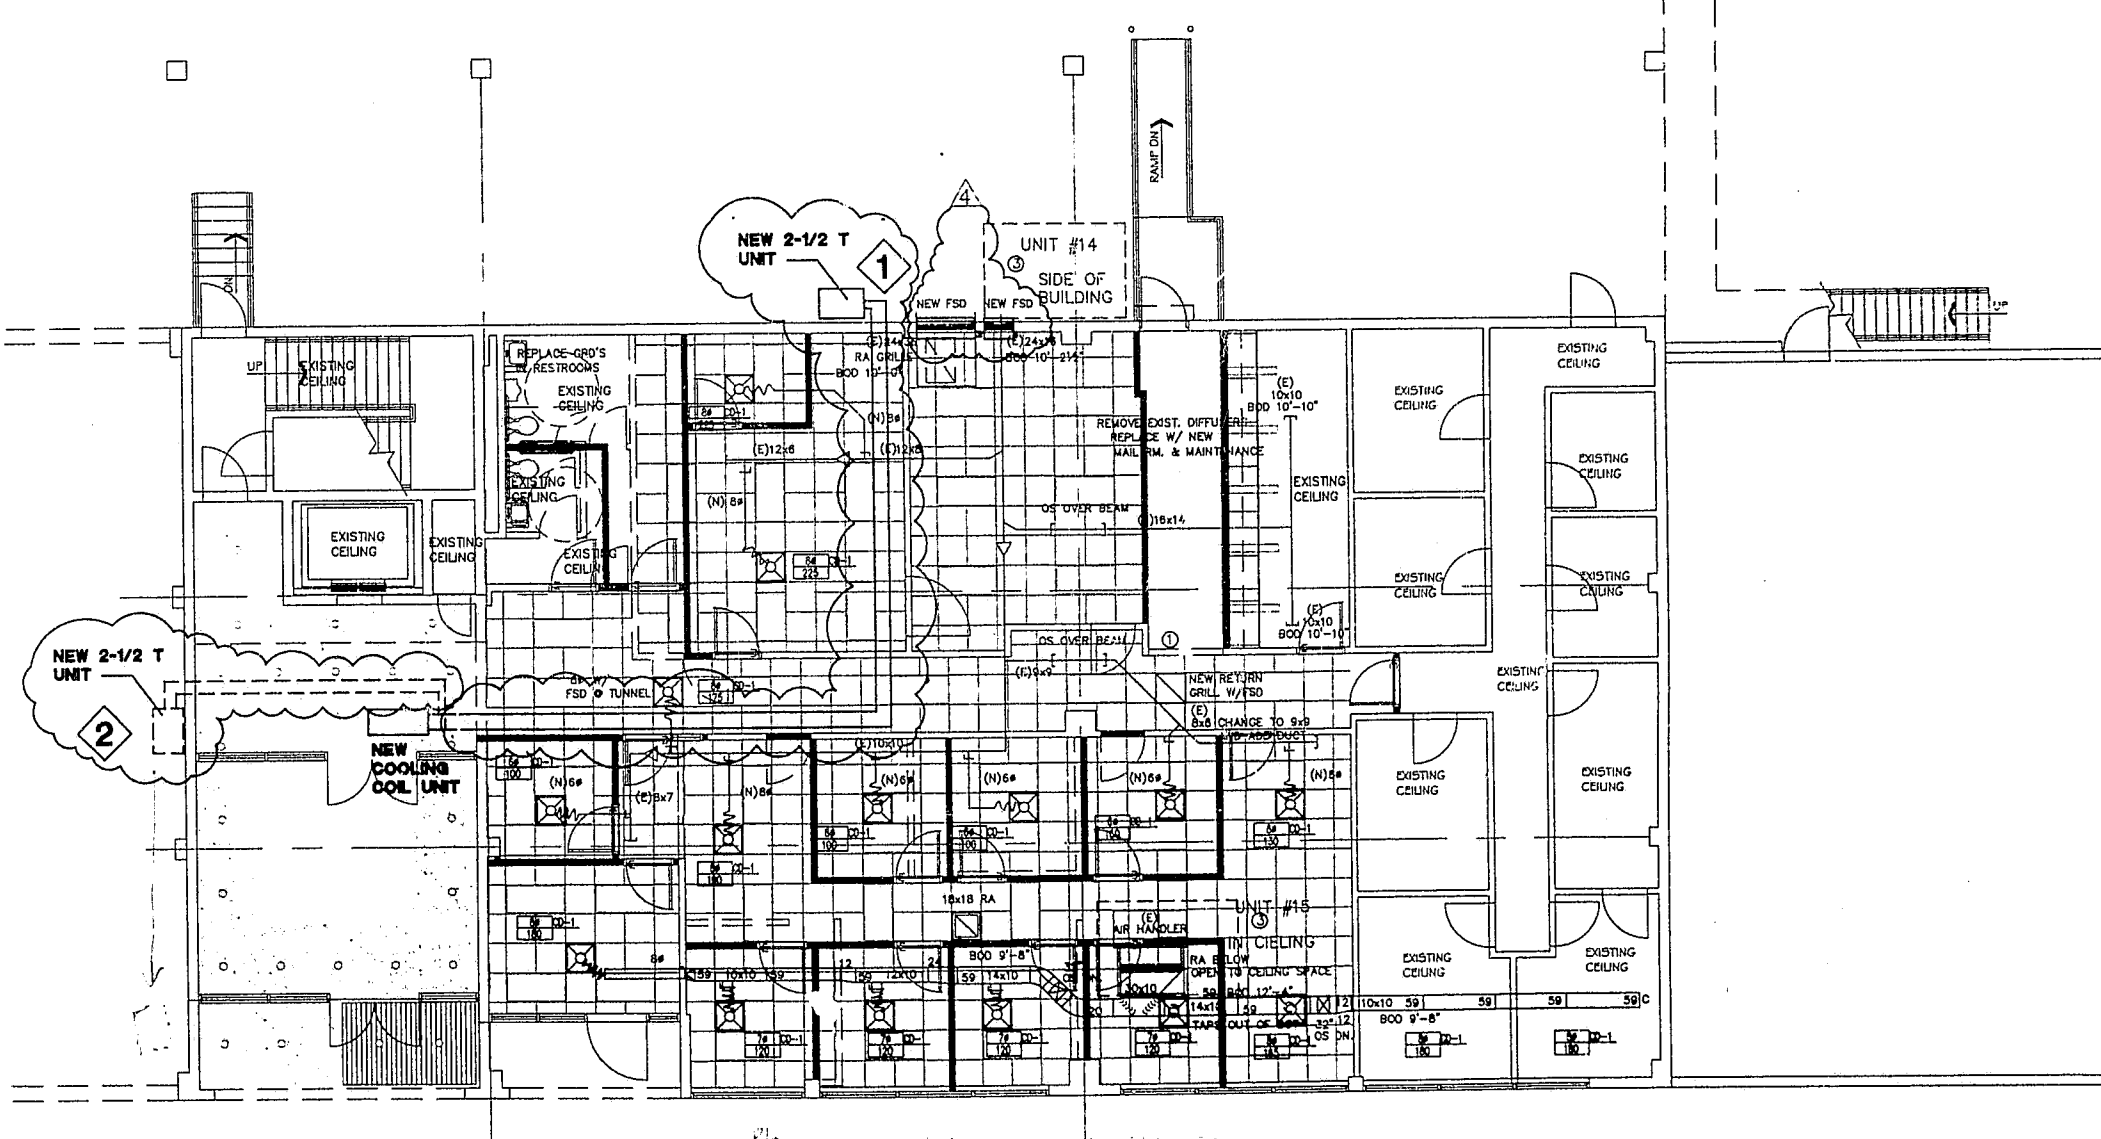

KEYED NOTES

- DUCT FROM NEW GRILL W/FSD TO BE ROUTED TO EXISTING DUCT SYSTEM.
- EXISTING DUCT IS DUCTBOARD. MUST BE REPLACED IN RATED CEILING AREA.
- UNIT #14 IS CONDENSOR FOR UNIT #15

GENERAL NOTES

- ALL EXISTING DUCT AND EQUIPMENT LOCATIONS SHOWN ARE APPROXIMATE LOCATIONS. TCM WAS NOT FURNISHED WITH AS BUILT DRAWINGS..

FIRST FLOOR HVAC & REFLECTED CEILING PLAN

1/8" = 1'-0"

OPTIONS

- OPTION 1 REAR OF BUILDING.
- OPTION 2 PARKING ENTRANCE.

HVAC 1ST FLOOR		Scale: 1/8"=1'-0"	Date: 10/28/98	Drawn by: RB	Rev. No.	
ART INSTITUTES INTL		Temp Control Mechanical Corp		4		
PORTLAND		1000 U STREET NORTH PORTLAND, ME 04106		REV	DATE	
2000 SW 5TH		"Proud Of Our Work!"		DESCRIPTION		
Job No. 5098		M1.1				